

PLUMBING FIXTURE SCHEDULE

SYMBOL	DESCRIPTION	CONNECTION		REMARKS
		OW	HW	
P-1	WATER CLOSET	1/2"	3"	FLOOR MOUNTED TANK TYPE
P-2	LAVATORY	1/2"	2"	
P-3	3 BOWL SINK	1/2"	2"	FREE STANDING, INDIRECT WASTE
E-1	EXTERIOR CLEANOUT			
E-2	FLOOR CLEANOUT			
F-1	FLOOR SINK			SEE FIRST FLOOR PLANS
F-2	FLOOR SINK			SEE FIRST FLOOR PLANS
WH	WALL HYPHYANT	3/4"	1"	PROVIDE BOX TYPE
BFP	BACKFLOW PREVENTER	1"		

GENERAL PLUMBING NOTES

1. ALL WORK SHALL BE IN ACCORDANCE WITH THE 2018 INTERNATIONAL PLUMBING CODE (IPC) AND THE 2018 INTERNATIONAL FIXTURES AND EQUIPMENT CODE (IFEC).

2. ALL WORK SHALL BE IN ACCORDANCE WITH THE 2018 INTERNATIONAL MECHANICAL CODE (IMC).

3. ALL WORK SHALL BE IN ACCORDANCE WITH THE 2018 INTERNATIONAL ELECTRICAL CODE (IEC).

4. ALL WORK SHALL BE IN ACCORDANCE WITH THE 2018 INTERNATIONAL FIRE AND ALARM CODE (IFAC).

5. ALL WORK SHALL BE IN ACCORDANCE WITH THE 2018 INTERNATIONAL BUILDING CODE (IBC).





6. ALL WORK SHALL BE IN ACCORDANCE WITH THE 2018 INTERNATIONAL ENERGY CONSERVATION CODE (IECC).

7. ALL WORK SHALL BE IN ACCORDANCE WITH THE 2018 INTERNATIONAL SWEET'S WATER SUPPLY AND WASTE DISPOSAL CODE (SWSWDC).

8. ALL WORK SHALL BE IN ACCORDANCE WITH THE 2018 INTERNATIONAL PLUMBING AND MECHANICAL CODE (IPMC).

9. ALL WORK SHALL BE IN ACCORDANCE WITH THE 2018 INTERNATIONAL PLUMBING AND MECHANICAL CODE (IPMC).

10. ALL WORK SHALL BE IN ACCORDANCE WITH THE 2018 INTERNATIONAL PLUMBING AND MECHANICAL CODE (IPMC).

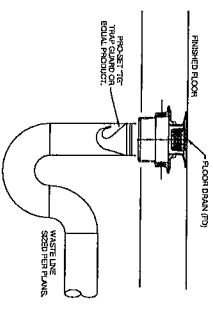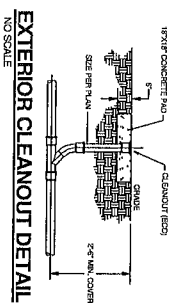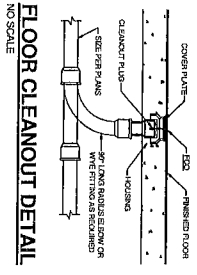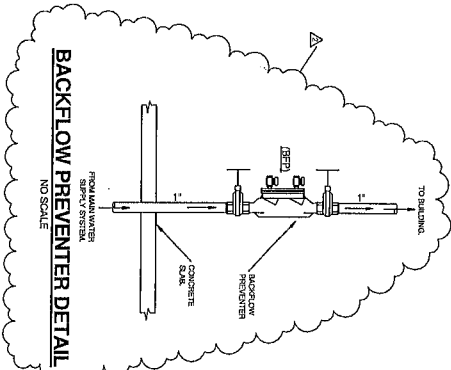

TENINFRASTRUCTURE
CONSULTING & ENGINEERING
ARCHITECTURE

70 Millwood Court
West Columbia, SC 29229
(803) 733-2222

Project Name: RIVER ROAD FIRE STATION
10716 River Road
Ridgeway, SC 29130

Project Number: 2101
Drawing Number: 5-2125

DATE: 01-25-2022
DRAWN BY: [Signature]
CHECKED BY: [Signature]

REVISIONS

NO.	Description	Date
1	Issue for Bid	01/25/22
2	Revised	02/02/22


Professional Engineer Seal: [Seal]

10716 River Road
Ridgeway, SC 29130

PLUMBING SCHEDULES & DETAILS

Sheet Number: 2101
Drawing Number: 5-2125

DATE: 01-25-2022

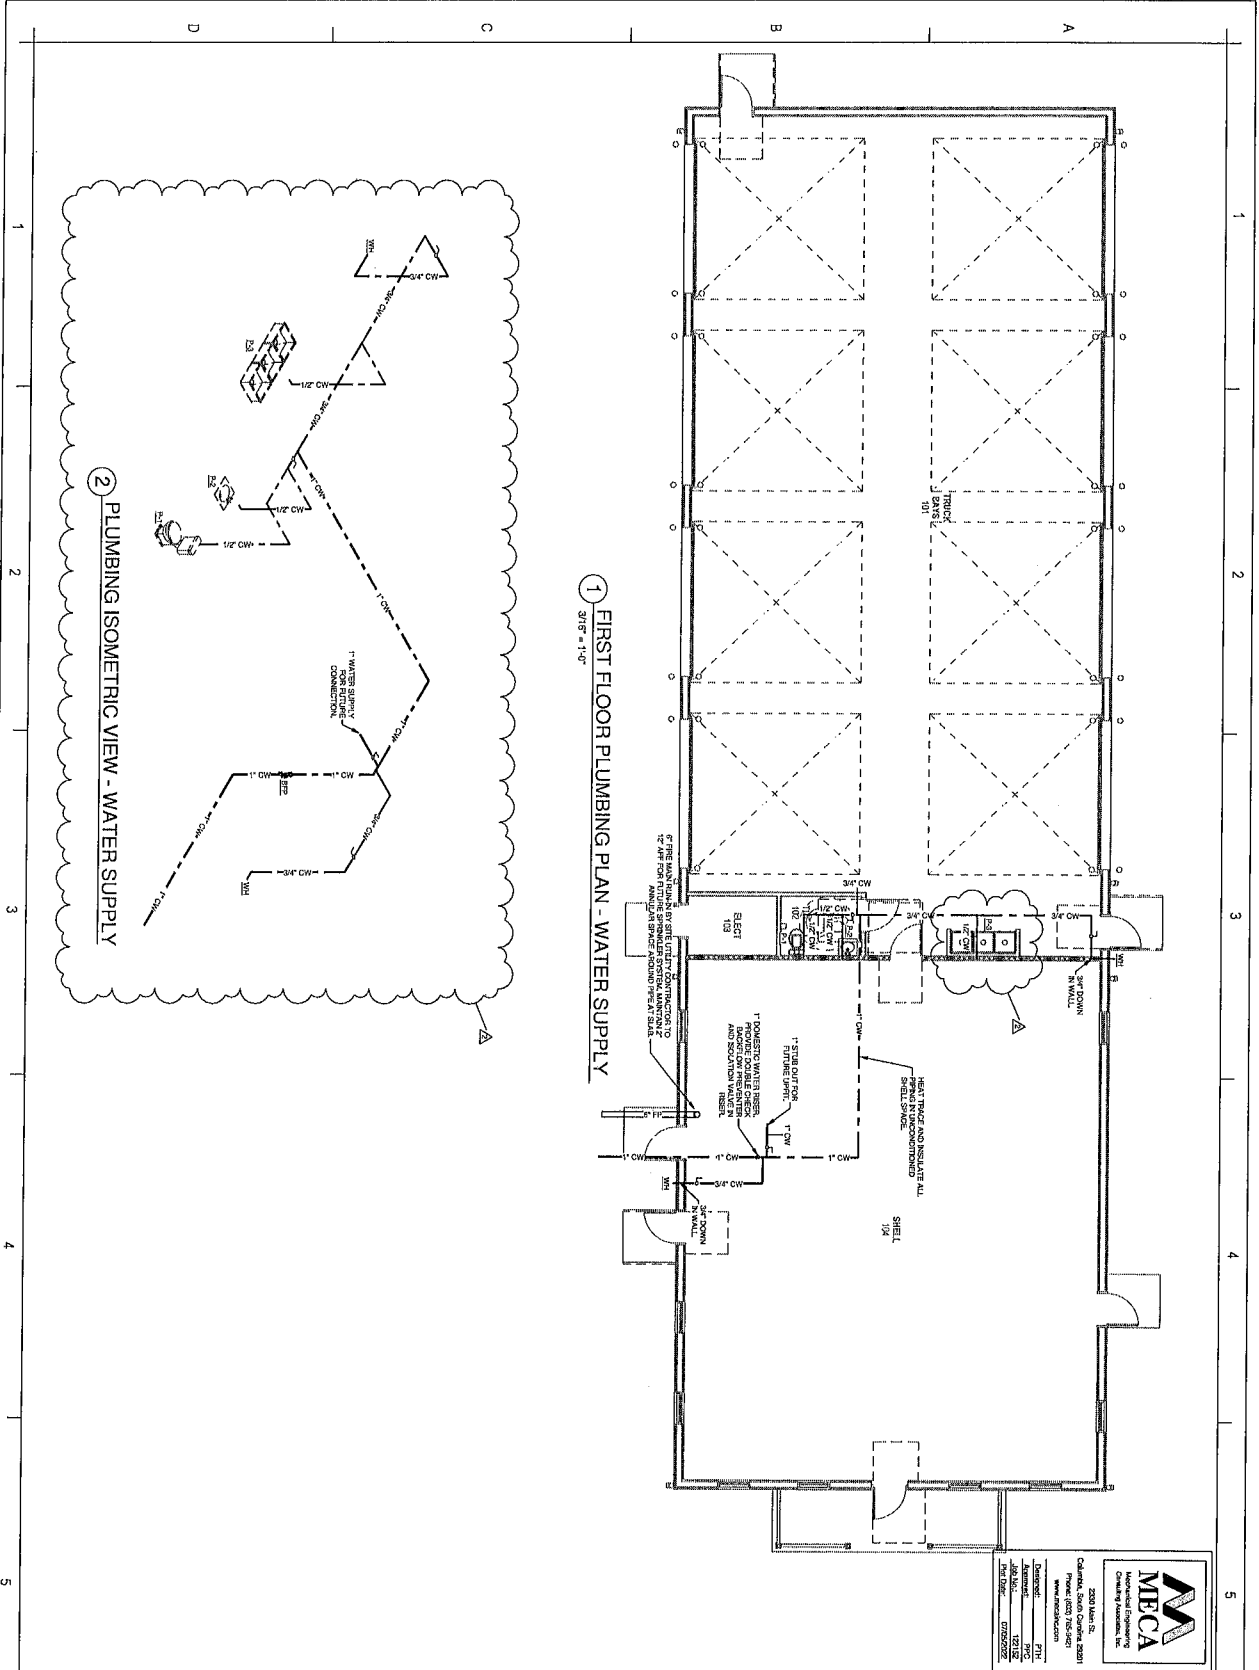

MECA
MECHANICAL
ELECTRICAL
CIVIL ENGINEERING

3000 BULLOCK
COLUMBIA, SC 29910
PH: 803.732.1800
FAX: 803.732.1801
WWW.MECAENGINEERS.COM

INFRASTRUCTURE
CONSULTING & ENGINEERING
ARCHITECTURE

33 McLeod Court
Walterboro, SC 29925
803.327.3333

REVISIONS

No.	Description	Date
1	Issued	06/20/22
2	Revised	06/20/22

PROJECT INFORMATION

RIVER ROAD FIRE STATION
10716 River Road
Ridgeway, SC 29130

PLUMBING FLOOR PLAN - WATER SUPPLY

Scale: 3/8" = 1'-0"
Drawing Number: P102
Project Number: N-2208